


FELLOWSHIP PRESBYTERIAN CHURCH

Greenville, South Carolina

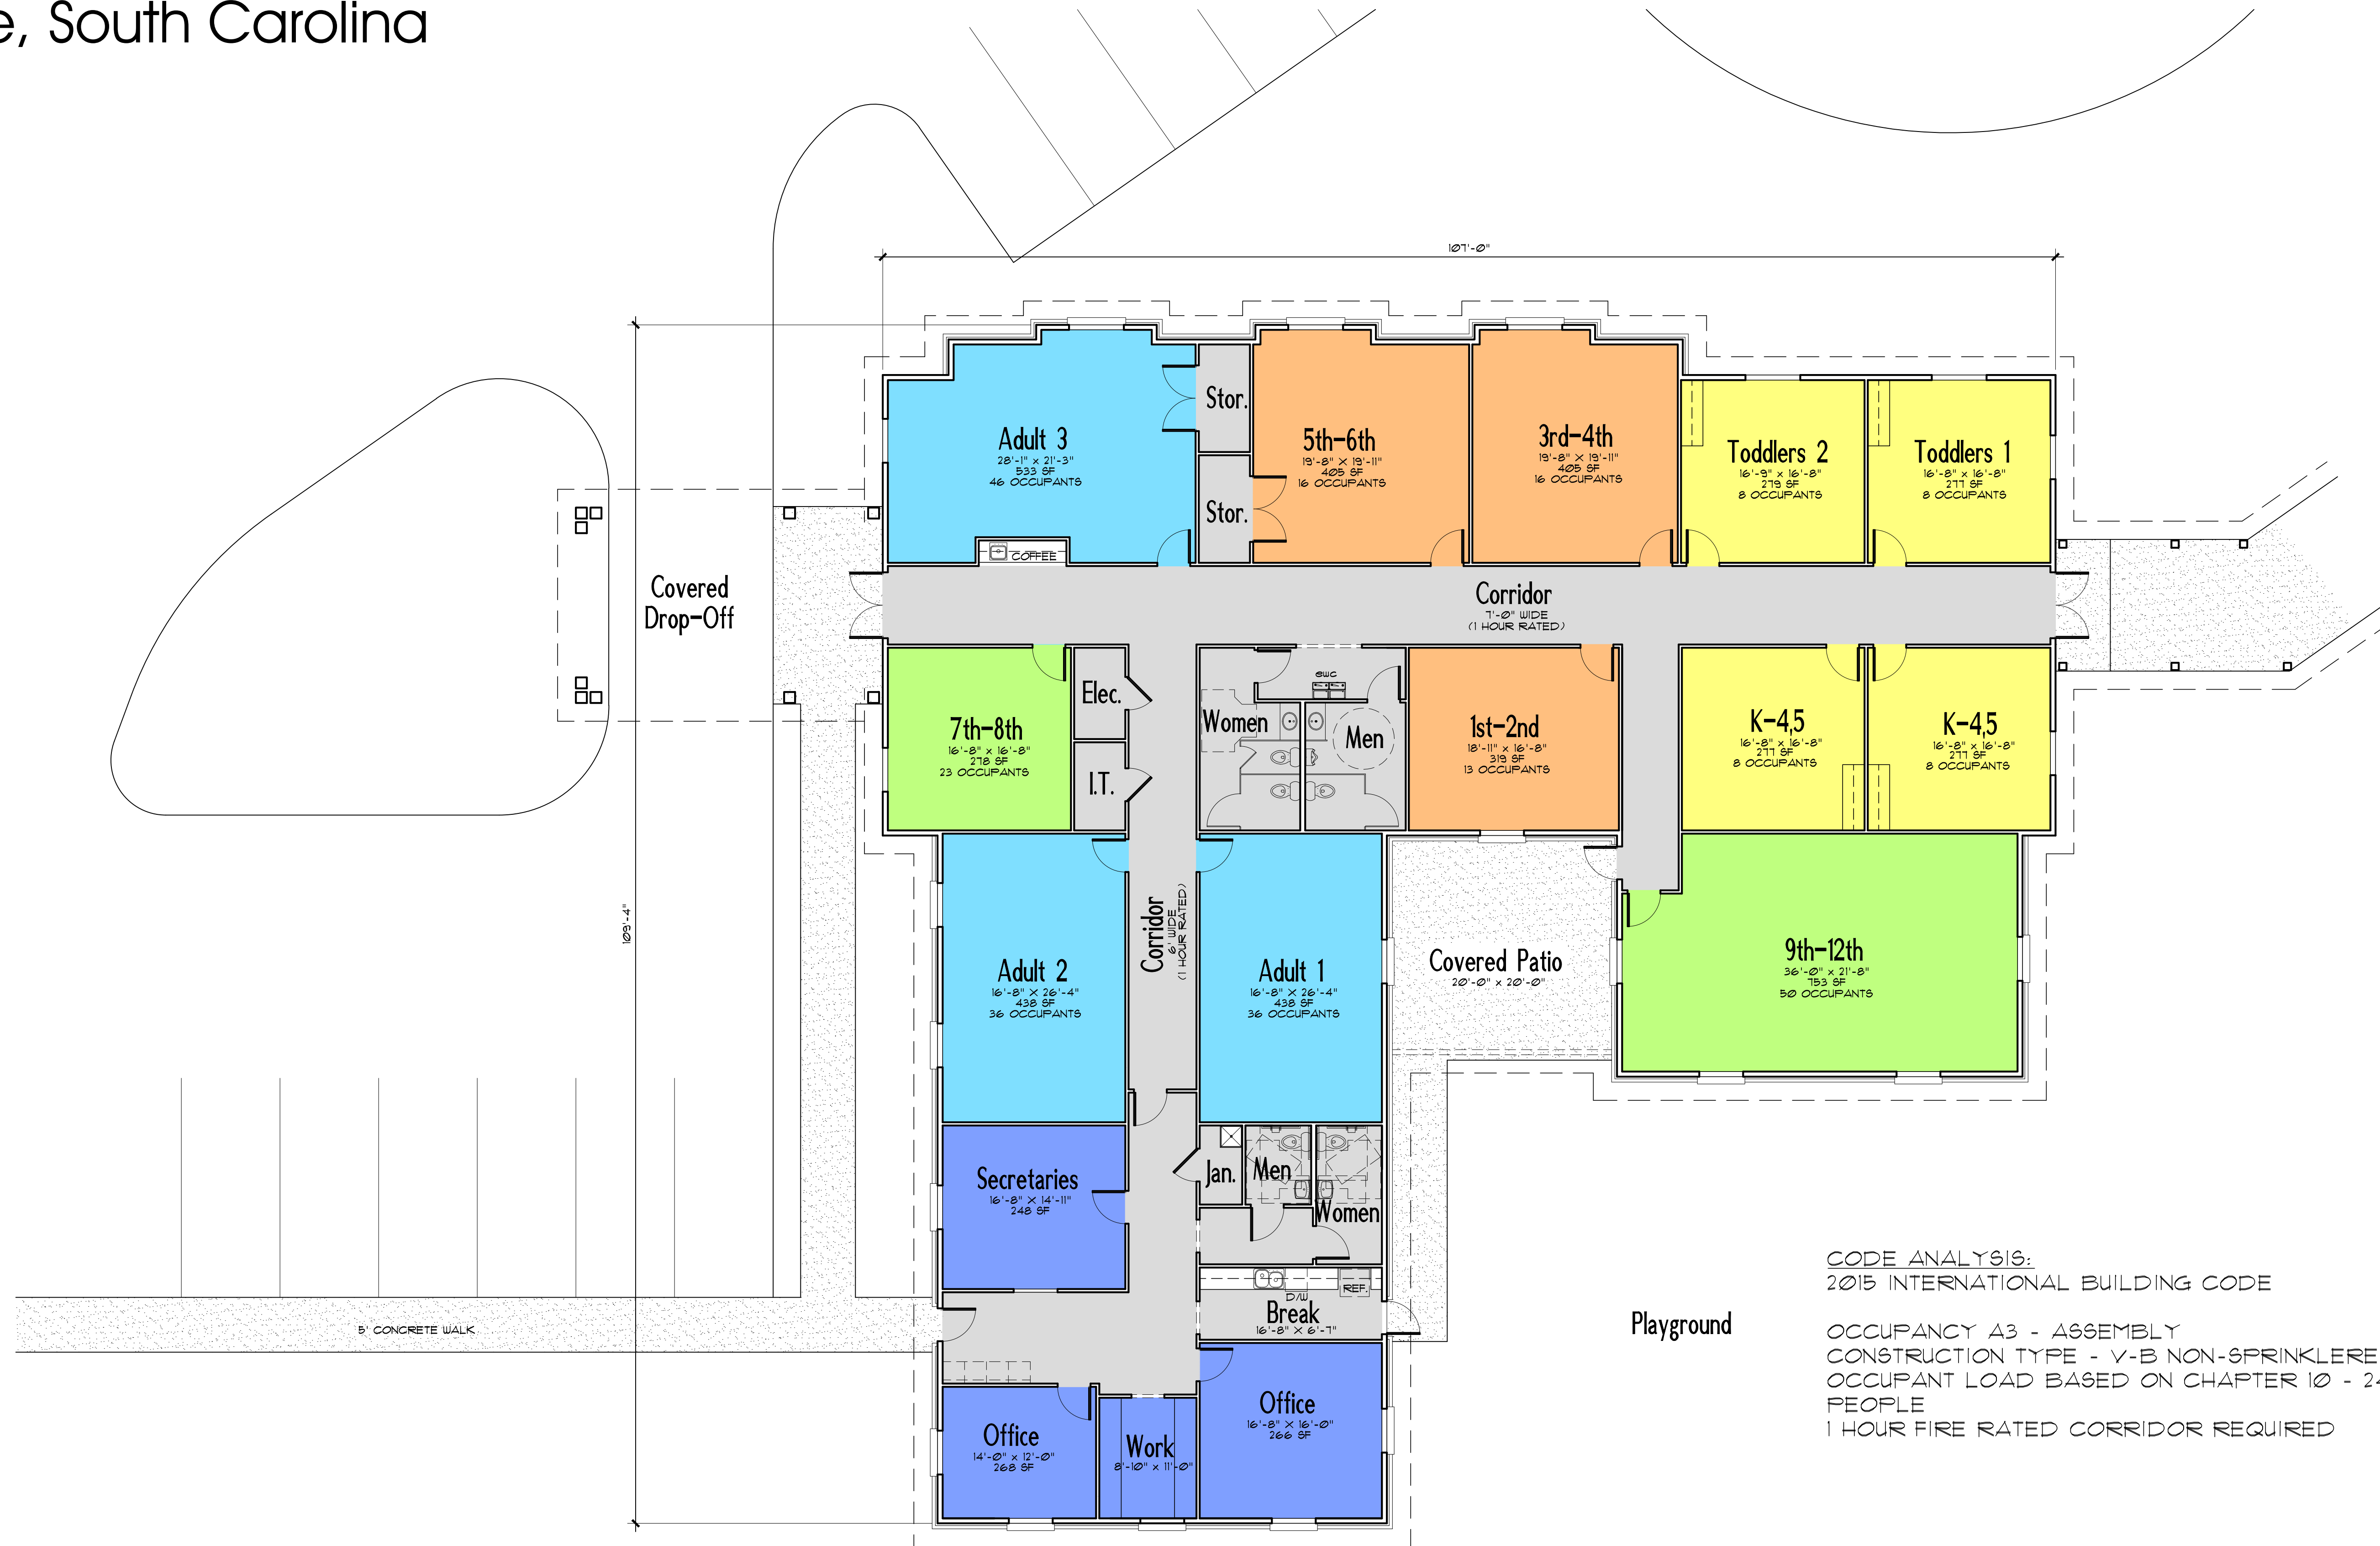

CODE ANALYSIS:
2015 INTERNATIONAL BUILDING CODE

OCCUPANCY A3 - ASSEMBLY
CONSTRUCTION TYPE - V-B NON-SPRINKLERED
OCCUPANT LOAD BASED ON CHAPTER 10 - 249
PEOPLE
1 HOUR FIRE RATED CORRIDOR REQUIRED

FLOOR PLAN
SCALE: 1/8" = 1'-0"

8,142 SQ. FT.



NORTH
7-3-19